




RECEIVED
19/08/2026
TOOWOOMBA
REGIONAL COUNCIL

DRAWING - ARCHITECTURAL		
SHEET	CONTENT	REV
A101	COVER PAGE	A
A102	PLAN	A
A103	ROOF	A
A104	ELEVATION	A
A105	ELEVATION	A
A106	SECTION	A
A107	ELEVATION WC	A
A108	ELEVATION SHOWER	A
A109	ELECTRICAL PLAN	A
A110	PLUMBING PLAN	A
A111	MECHANICAL PLAN	A

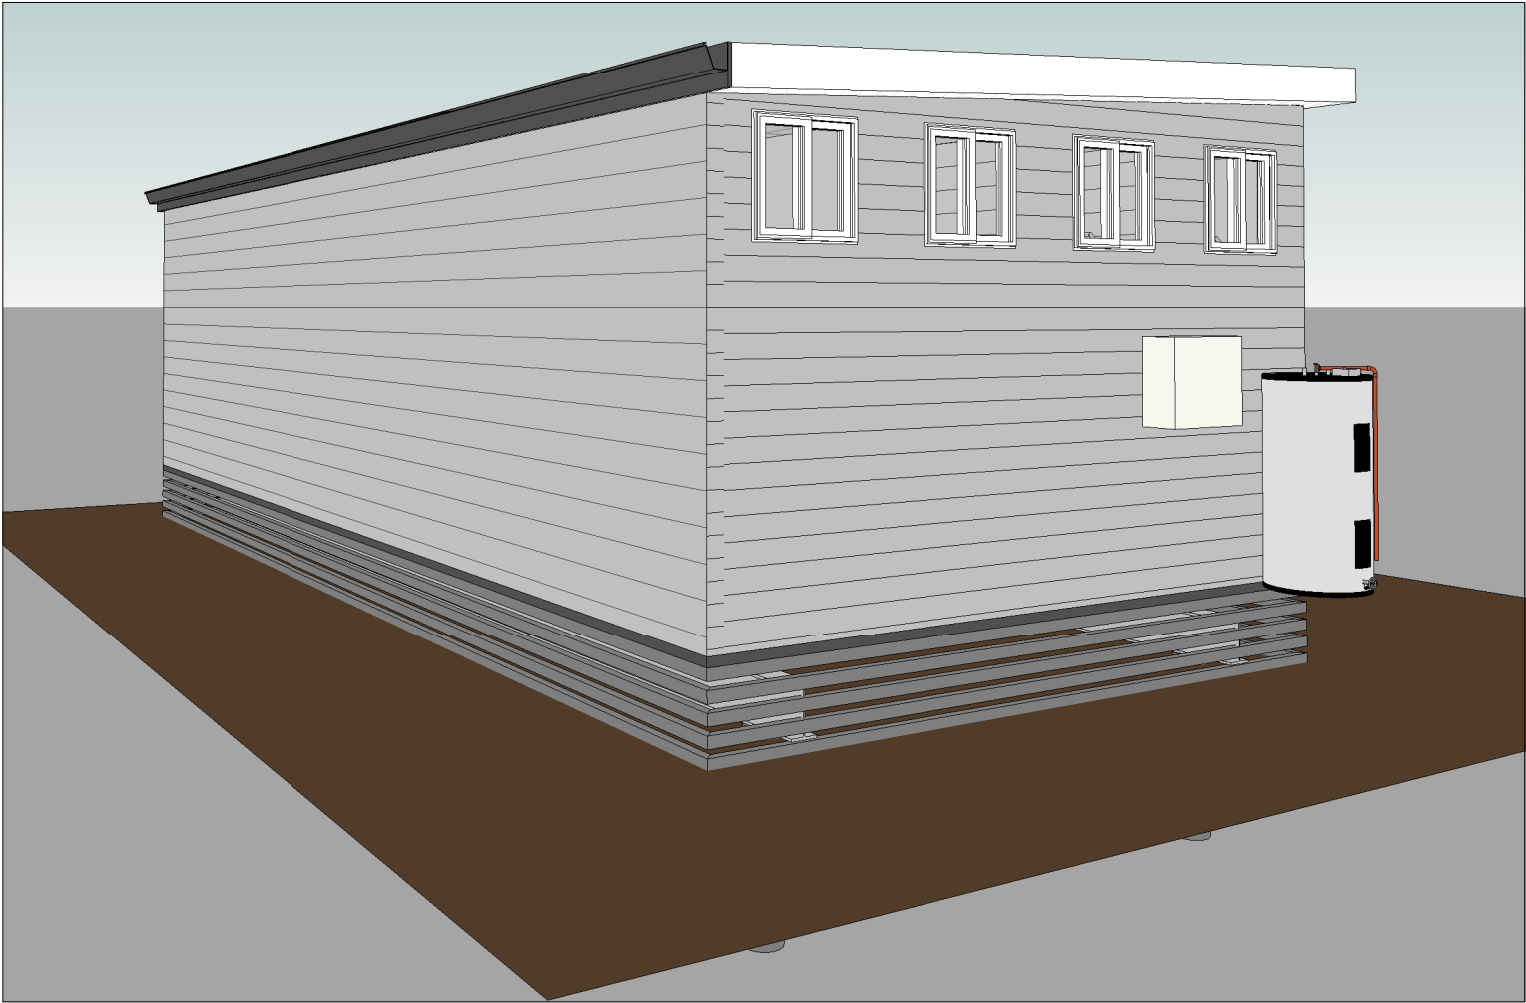

REVISION A	DRAFT JUNE 2025
REVISION B	
REVISION C	

MANUFACTURER



DESIGN



CLIENT



PROJECT

GRACE LUTHERAN COLLEGE

DRAWING TITLE

COVER PAGE

DRAWING STATUS
100% ISSUE

SCALE @ A3


DATE
JUNE 2025

DRAWN
QeCAD

PROJECT No
142

DRAWING NO
A101

ISSUE

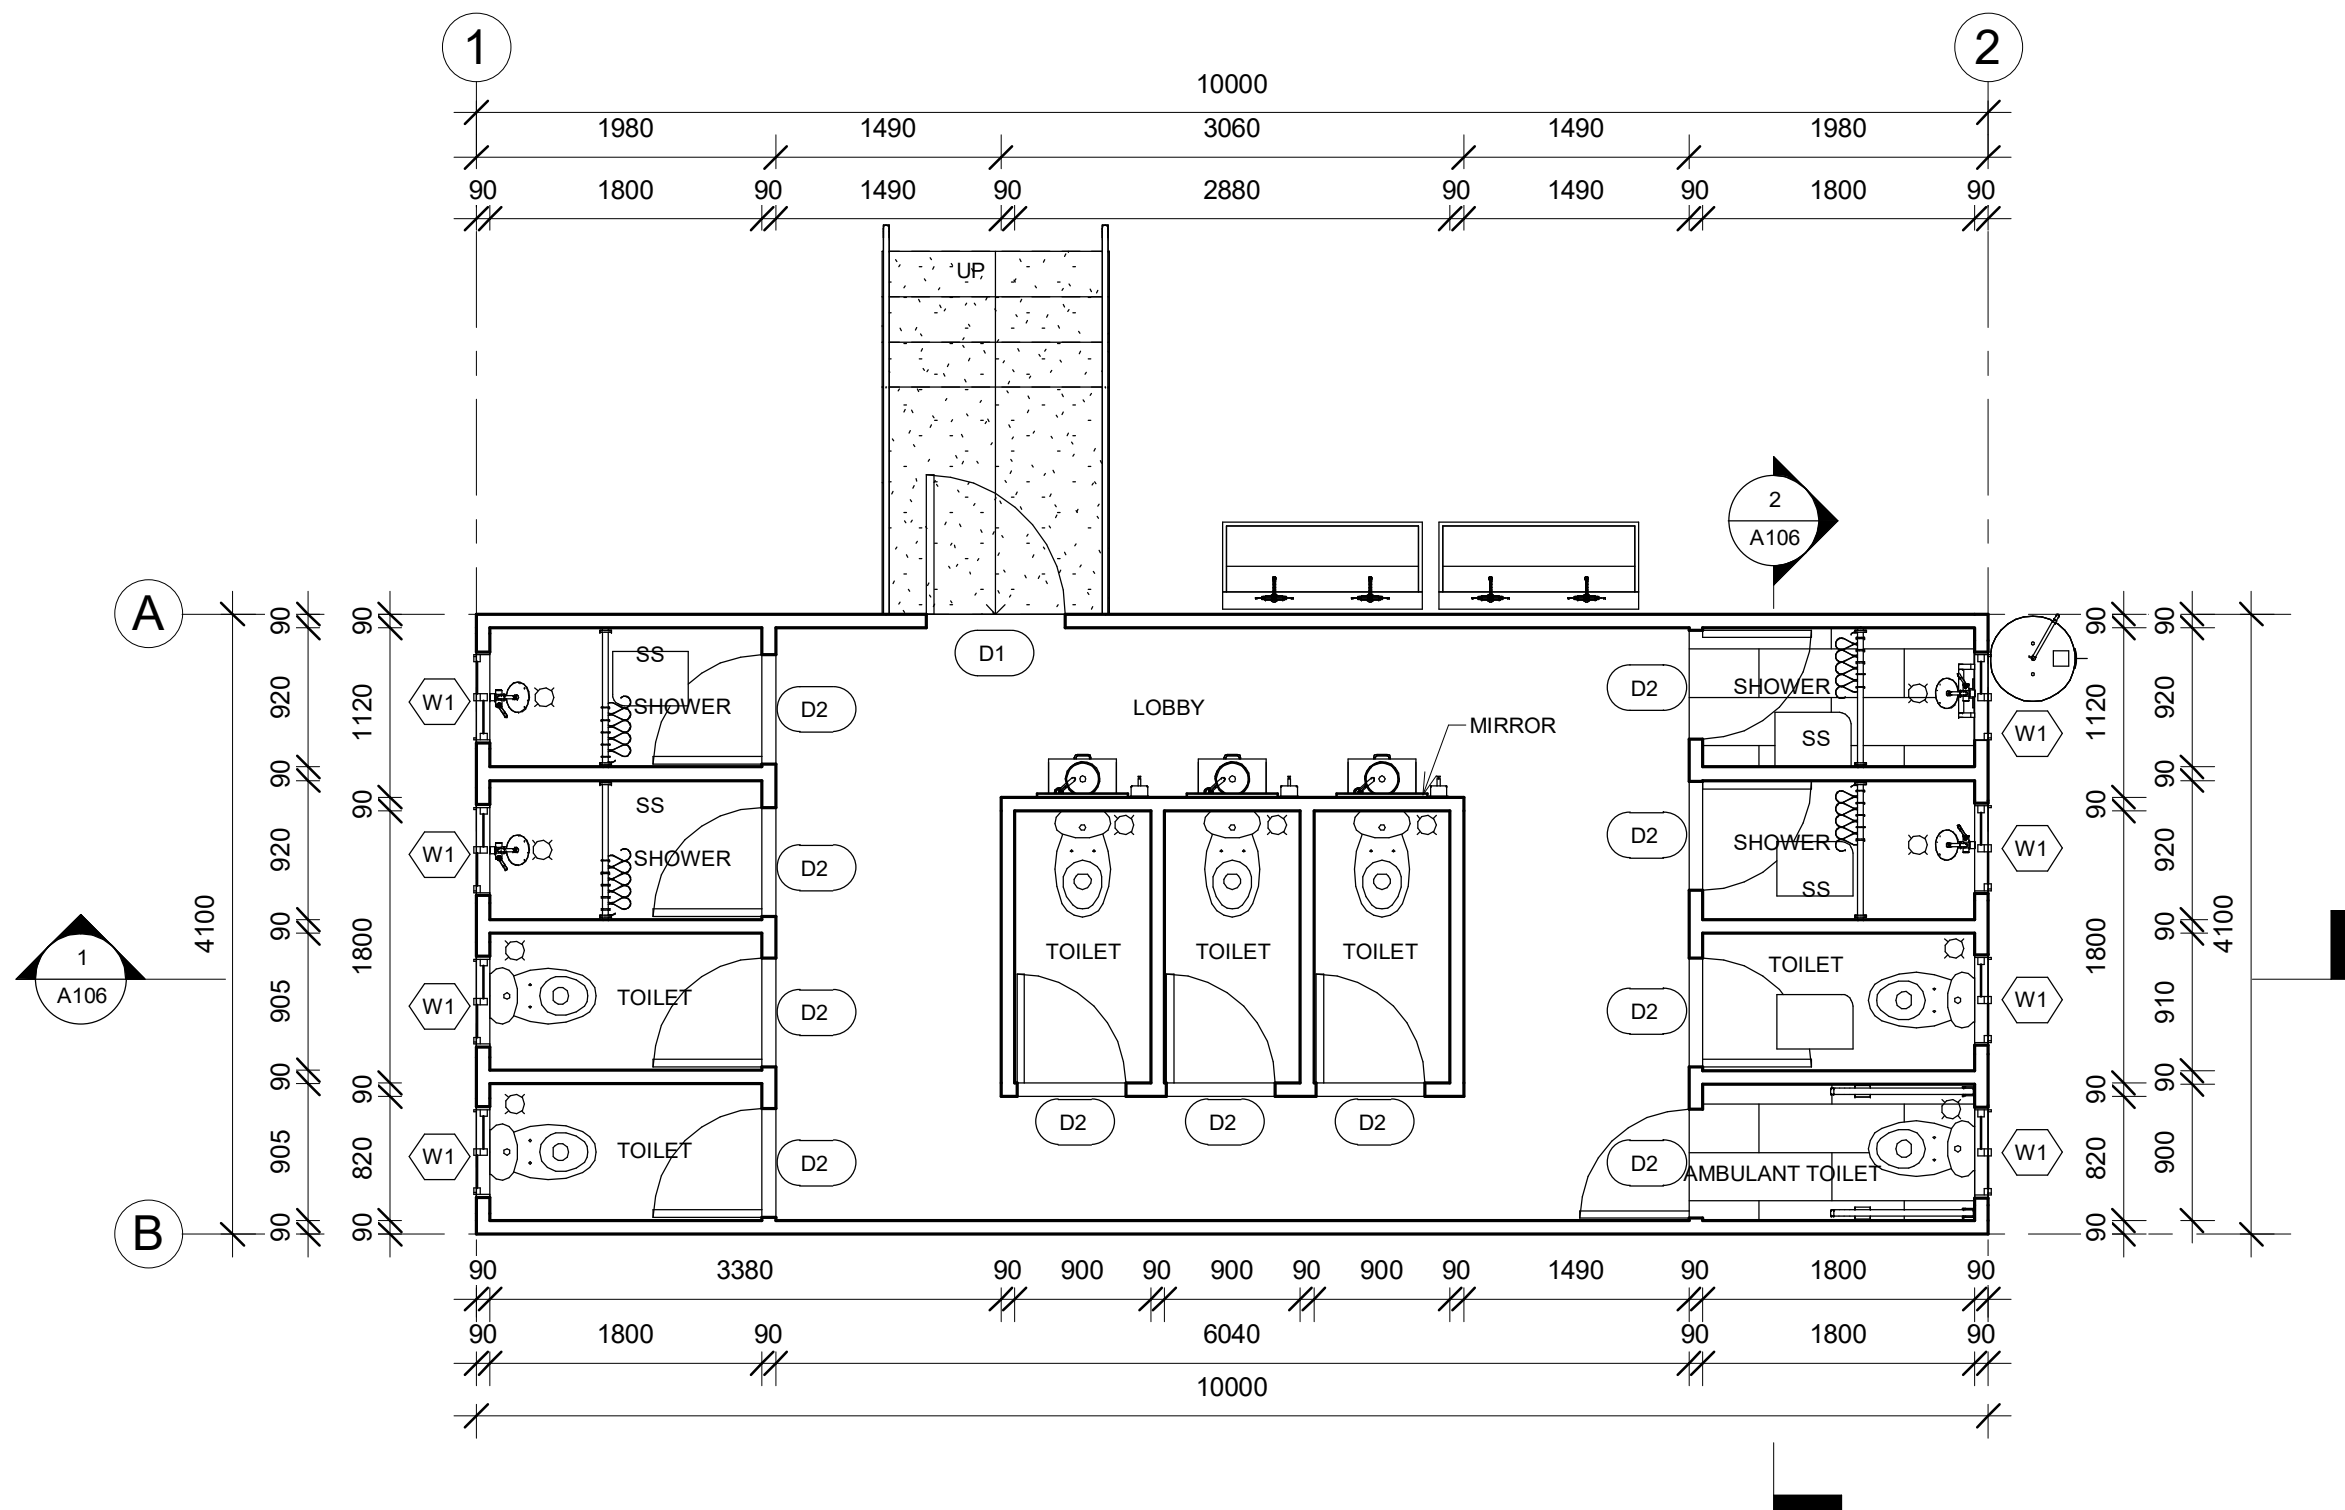

1 FLOOR LEVEL

WINDOW SCHEDULE					
TYPE MARK	WIDTH	HEIGHT	SILL HEIGHT	HEAD HEIGHT	COUNT
W1	600	600	1840	2440	8

DOOR SCHEDULE					
TYPE	TYPE MARK	WIDTH	HEIGHT	SILL HEIGHT	COUNT
SINGLE FLUSH	D1	920	2040	0	1
SINGLE FLUSH	D2	720	1900	100	11

REVISION A	DRAFT JUNE 2025
REVISION B	
REVISION C	

MANUFACTURER



PEGASUS MODULAR DESIGN & CONSTRUCT

DESIGN



PEGASUS MODULAR DESIGN & CONSTRUCT

CLIENT



CONSTRUCTION PROJECTS & FIT-OUTS

PROJECT

GRACE LUTHERAN COLLEGE

DRAWING TITLE

PLAN

DRAWING STATUS
100% ISSUE

SCALE @ A3
1 : 50


PROJECT No
142

DATE
JUNE 2025

DRAWING NO
A102

DRAWN
QeCAD

ISSUE

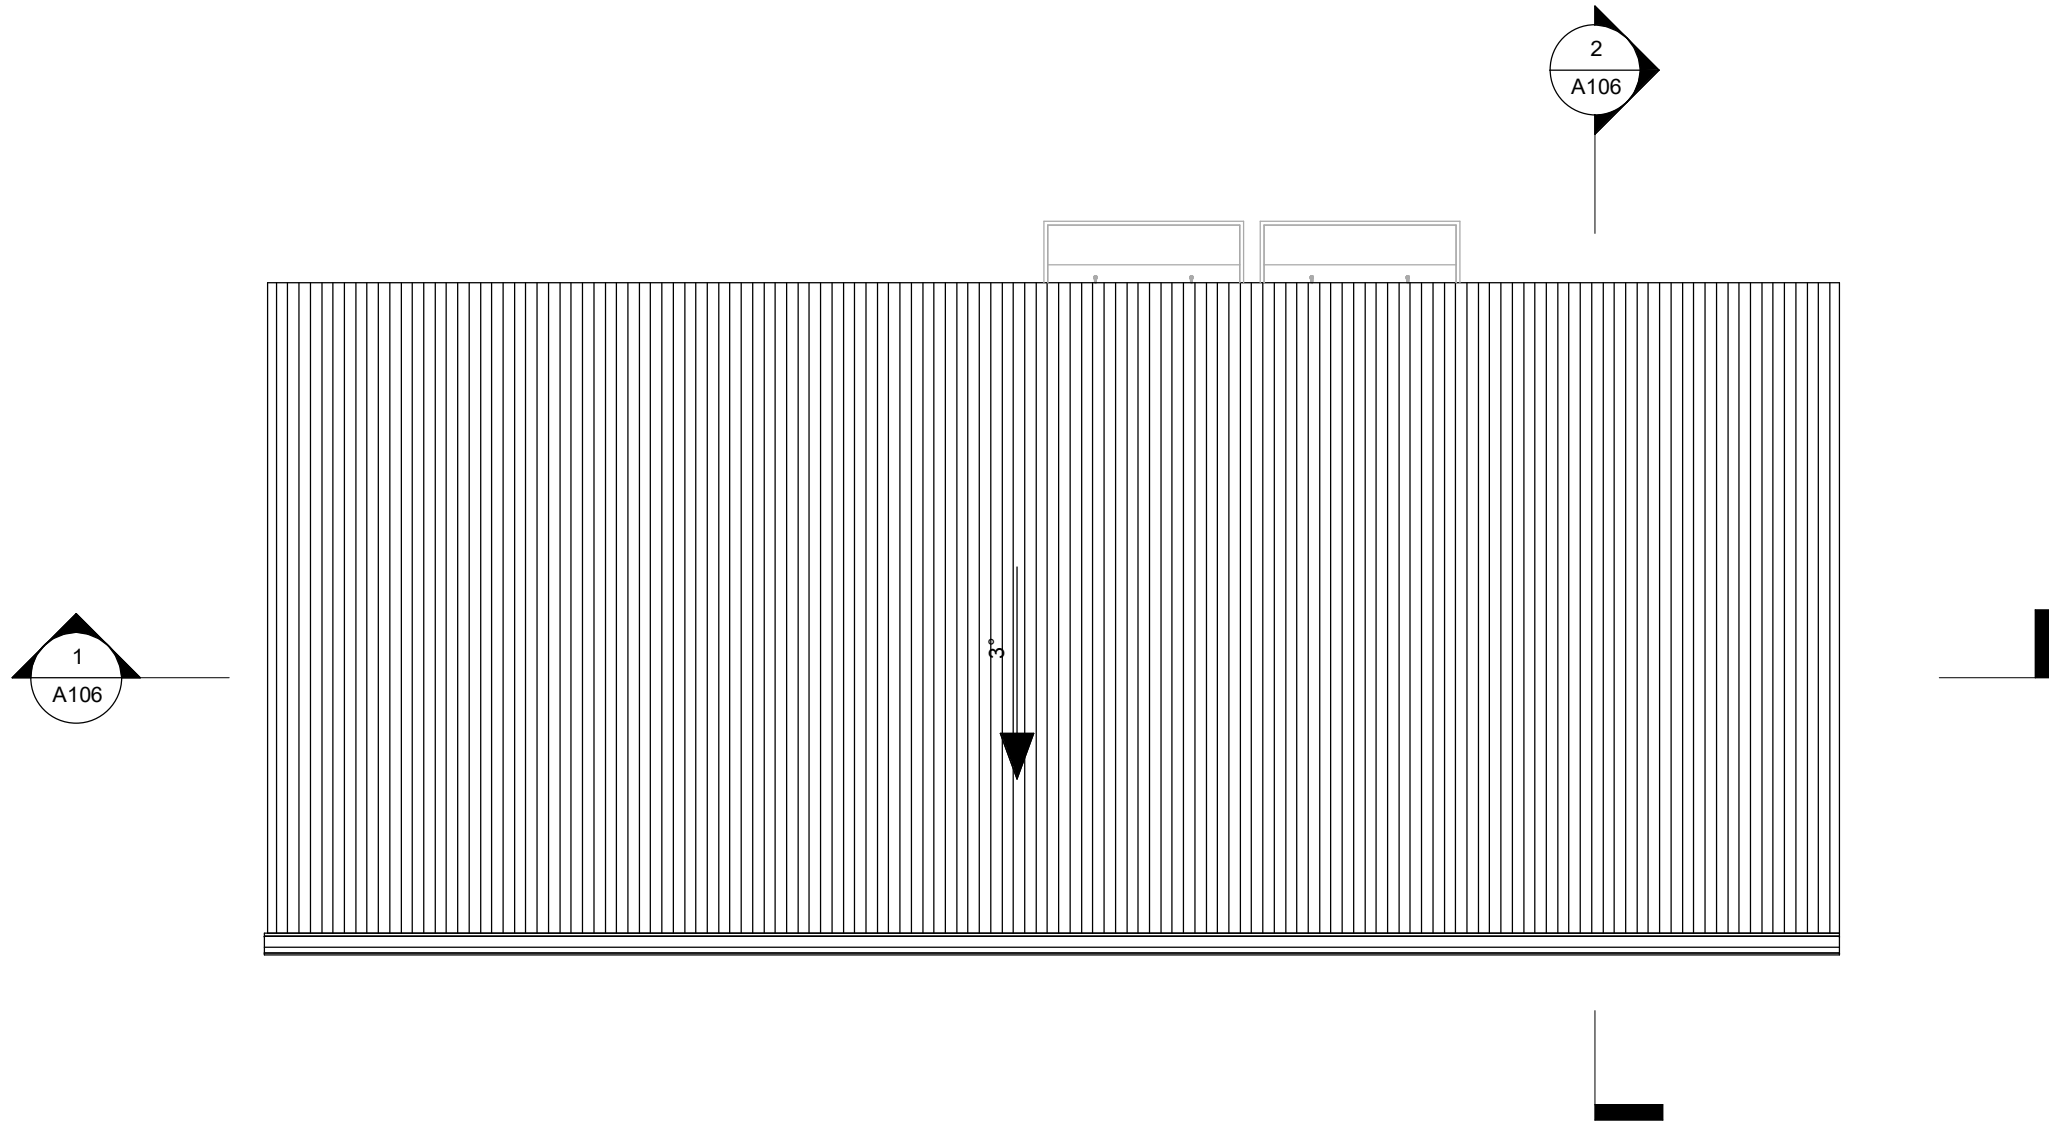

1

ROOF PLAN

REVISION A	DRAFT JUNE 2025
REVISION B	
REVISION C	

MANUFACTURER



DESIGN



CLIENT



PROJECT


GRACE LUTHERAN COLLEGE

DRAWING TITLE


ROOF

DRAWING STATUS
100% ISSUE

SCALE @ A3 1 : 50	DATE JUNE 2025	DRAWN QeCAD
PROJECT No 142	DRAWING NO A103	ISSUE

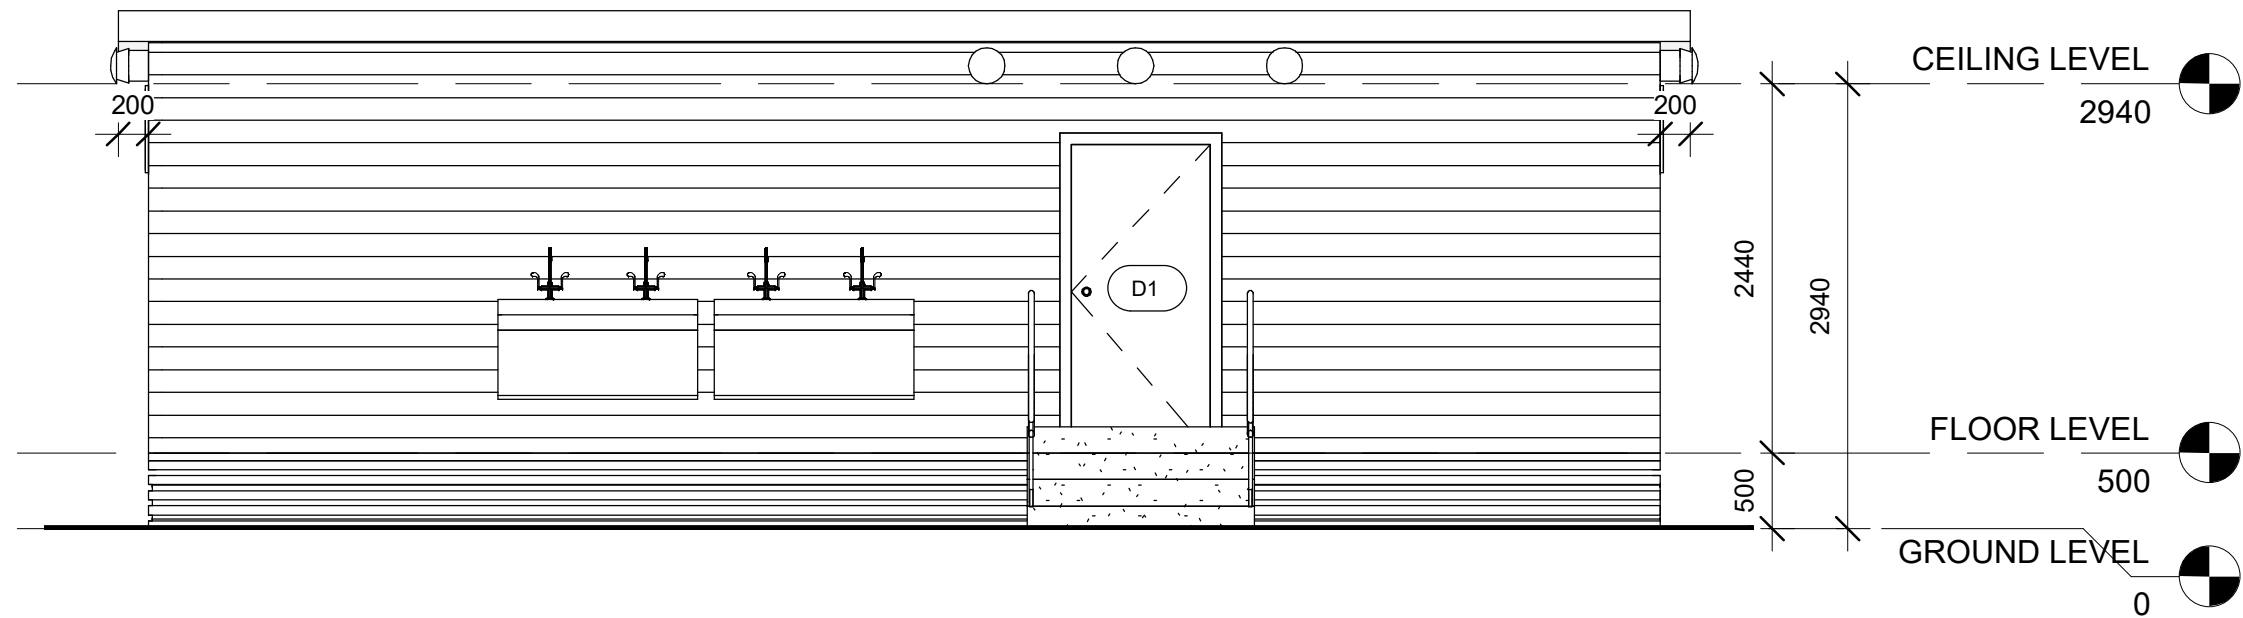

1 FRONT ELEVATION

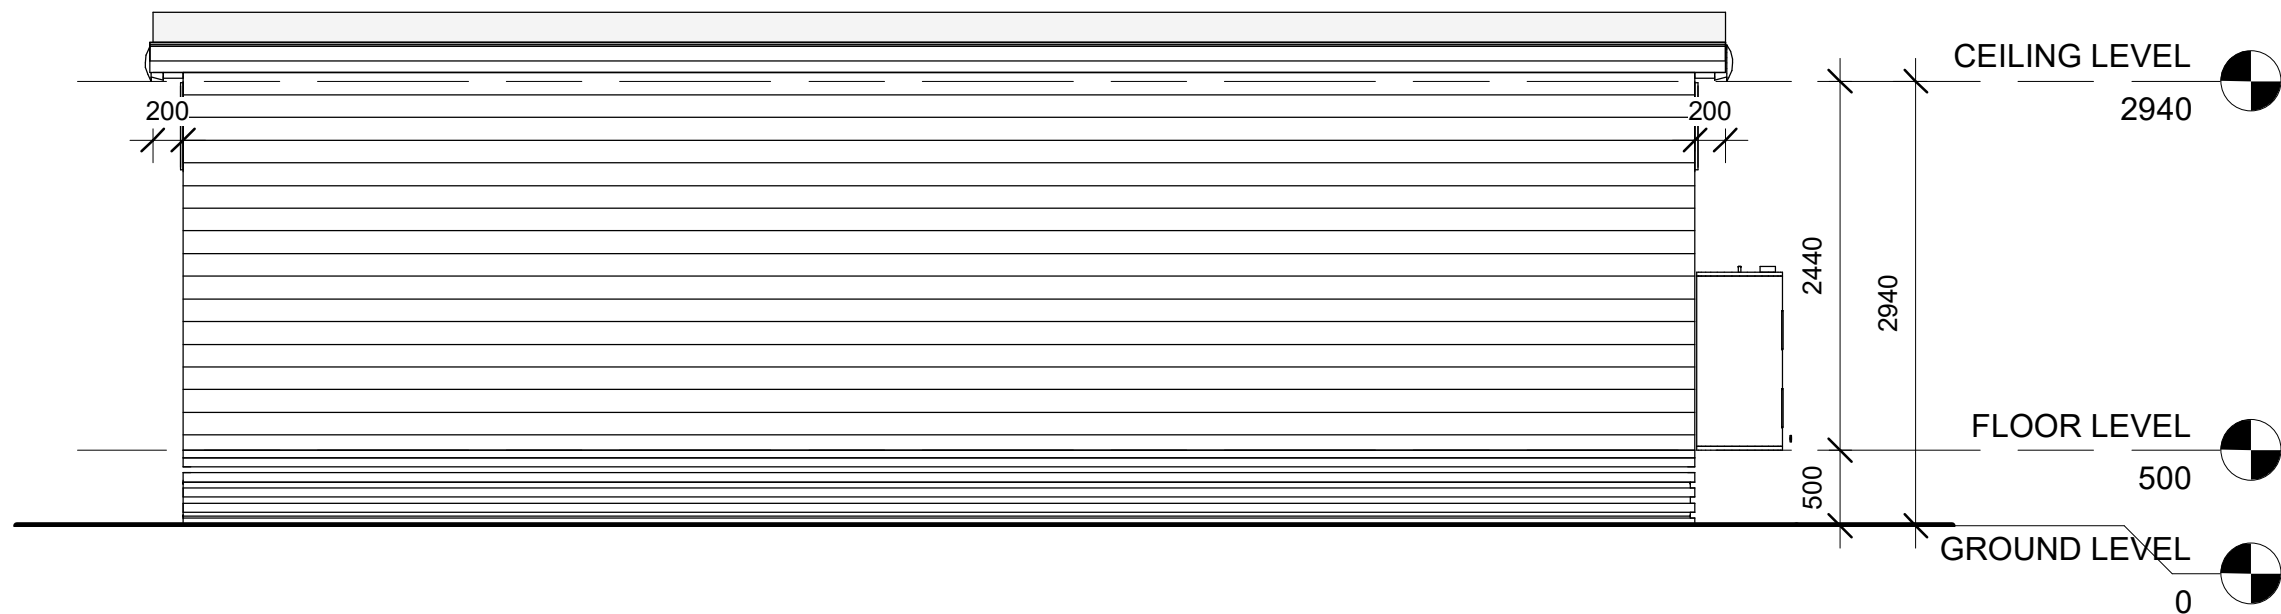

2 BACK ELEVATION

REVISION A	DRAFT JUNE 2025
REVISION B	
REVISION C	

MANUFACTURER

 **Pegasus**
MODULAR DESIGN & CONSTRUCT

PEGASUS MODULAR DESIGN & CONSTRUCT

DESIGN

 **Pegasus**
MODULAR DESIGN & CONSTRUCT

PEGASUS MODULAR DESIGN & CONSTRUCT

CLIENT

 **COOPER COMMERCIAL**
CONSTRUCTION PROJECTS & FIT-OUTS


PROJECT

GRACE LUTHERAN COLLEGE


DRAWING TITLE

ELEVATION

DRAWING STATUS 100% ISSUE		
SCALE @ A3 1 : 50	DATE JUNE 2025	DRAWN QeCAD
PROJECT No 142	DRAWING NO A104	ISSUE

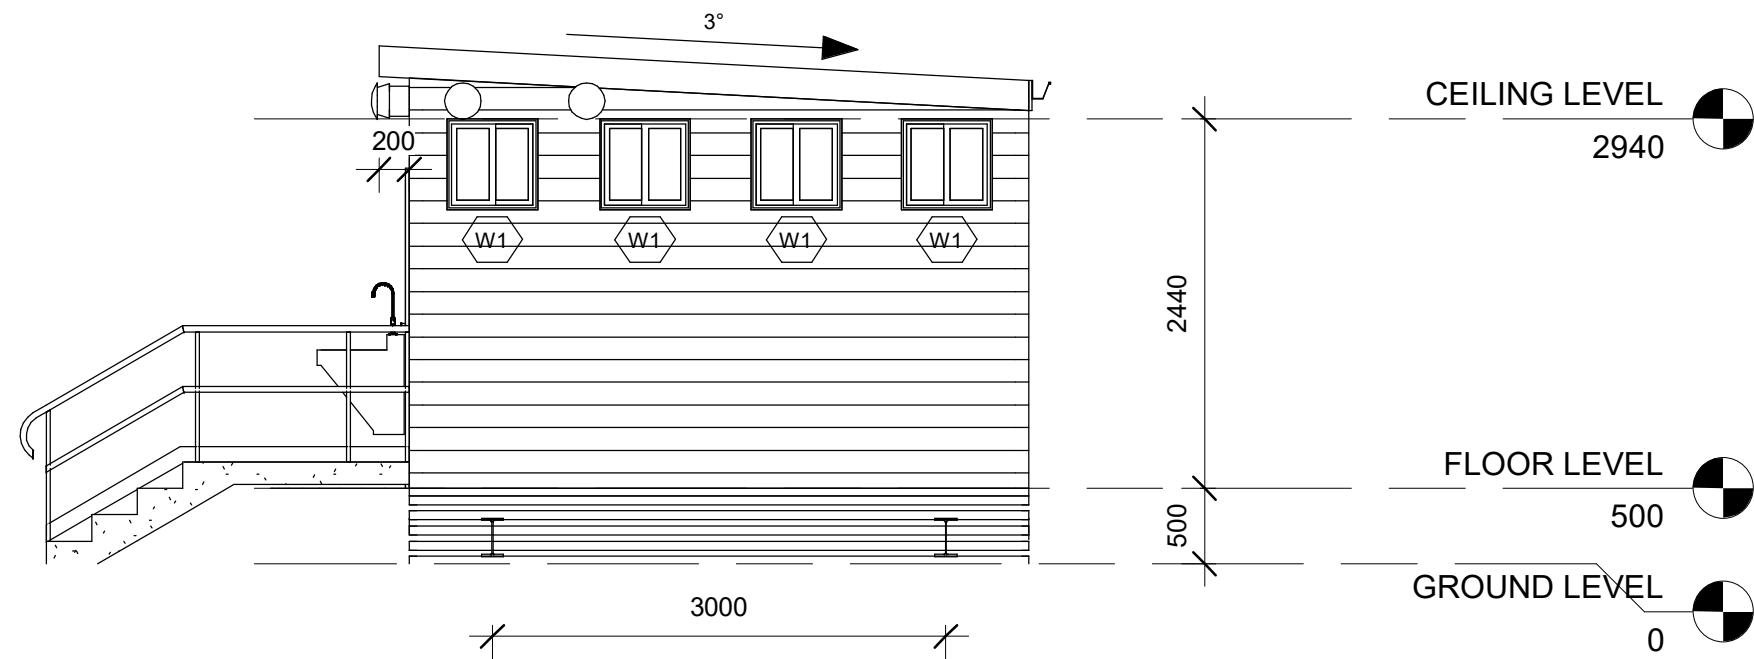

1 SIDE ELEVATION

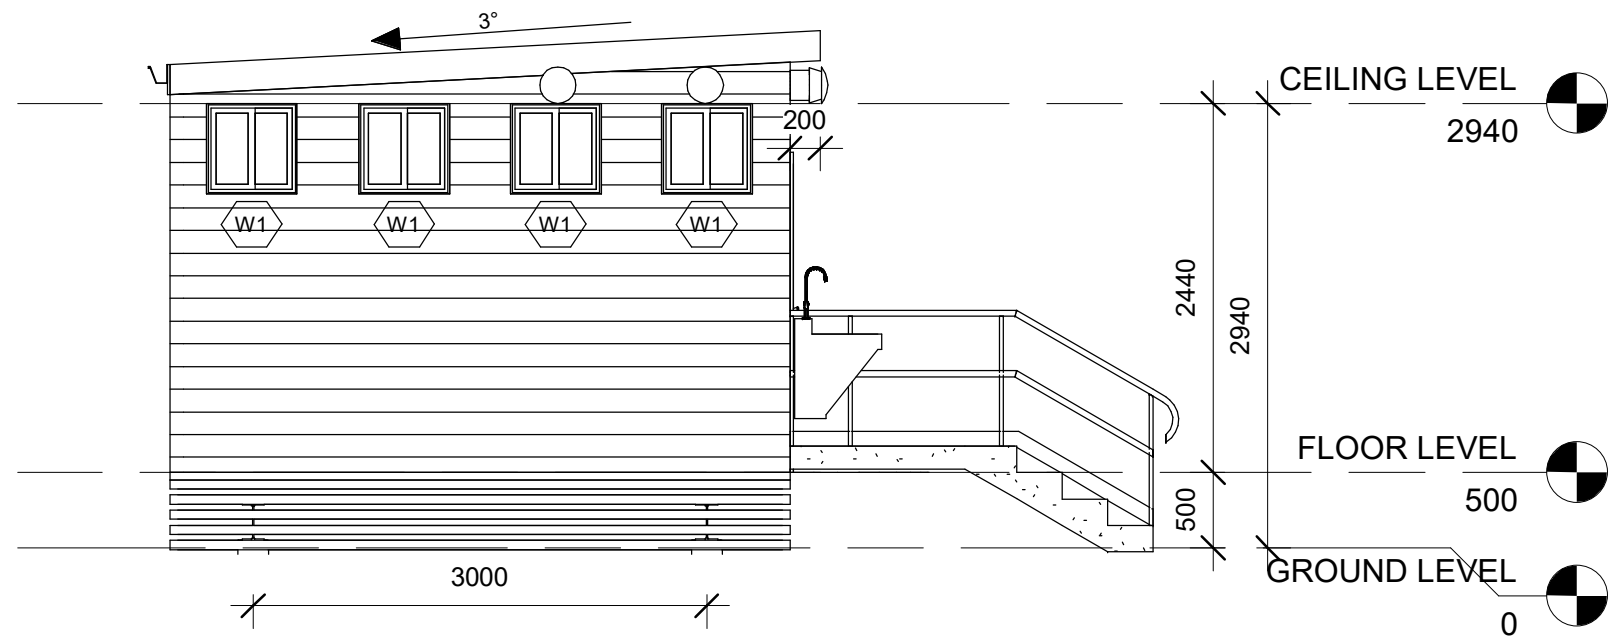

2 SIDE ELEVATION

REVISION A	DRAFT JUNE 2025
REVISION B	
REVISION C	

MANUFACTURER



PEGASUS MODULAR DESIGN & CONSTRUCT

DESIGN



PEGASUS MODULAR DESIGN & CONSTRUCT

CLIENT



PROJECT

GRACE LUTHERAN COLLEGE

DRAWING TITLE

ELEVATION

DRAWING STATUS
100% ISSUE

SCALE @ A3 1 : 50	DATE JUNE 2025	DRAWN QeCAD
PROJECT No 142	DRAWING NO A105	ISSUE